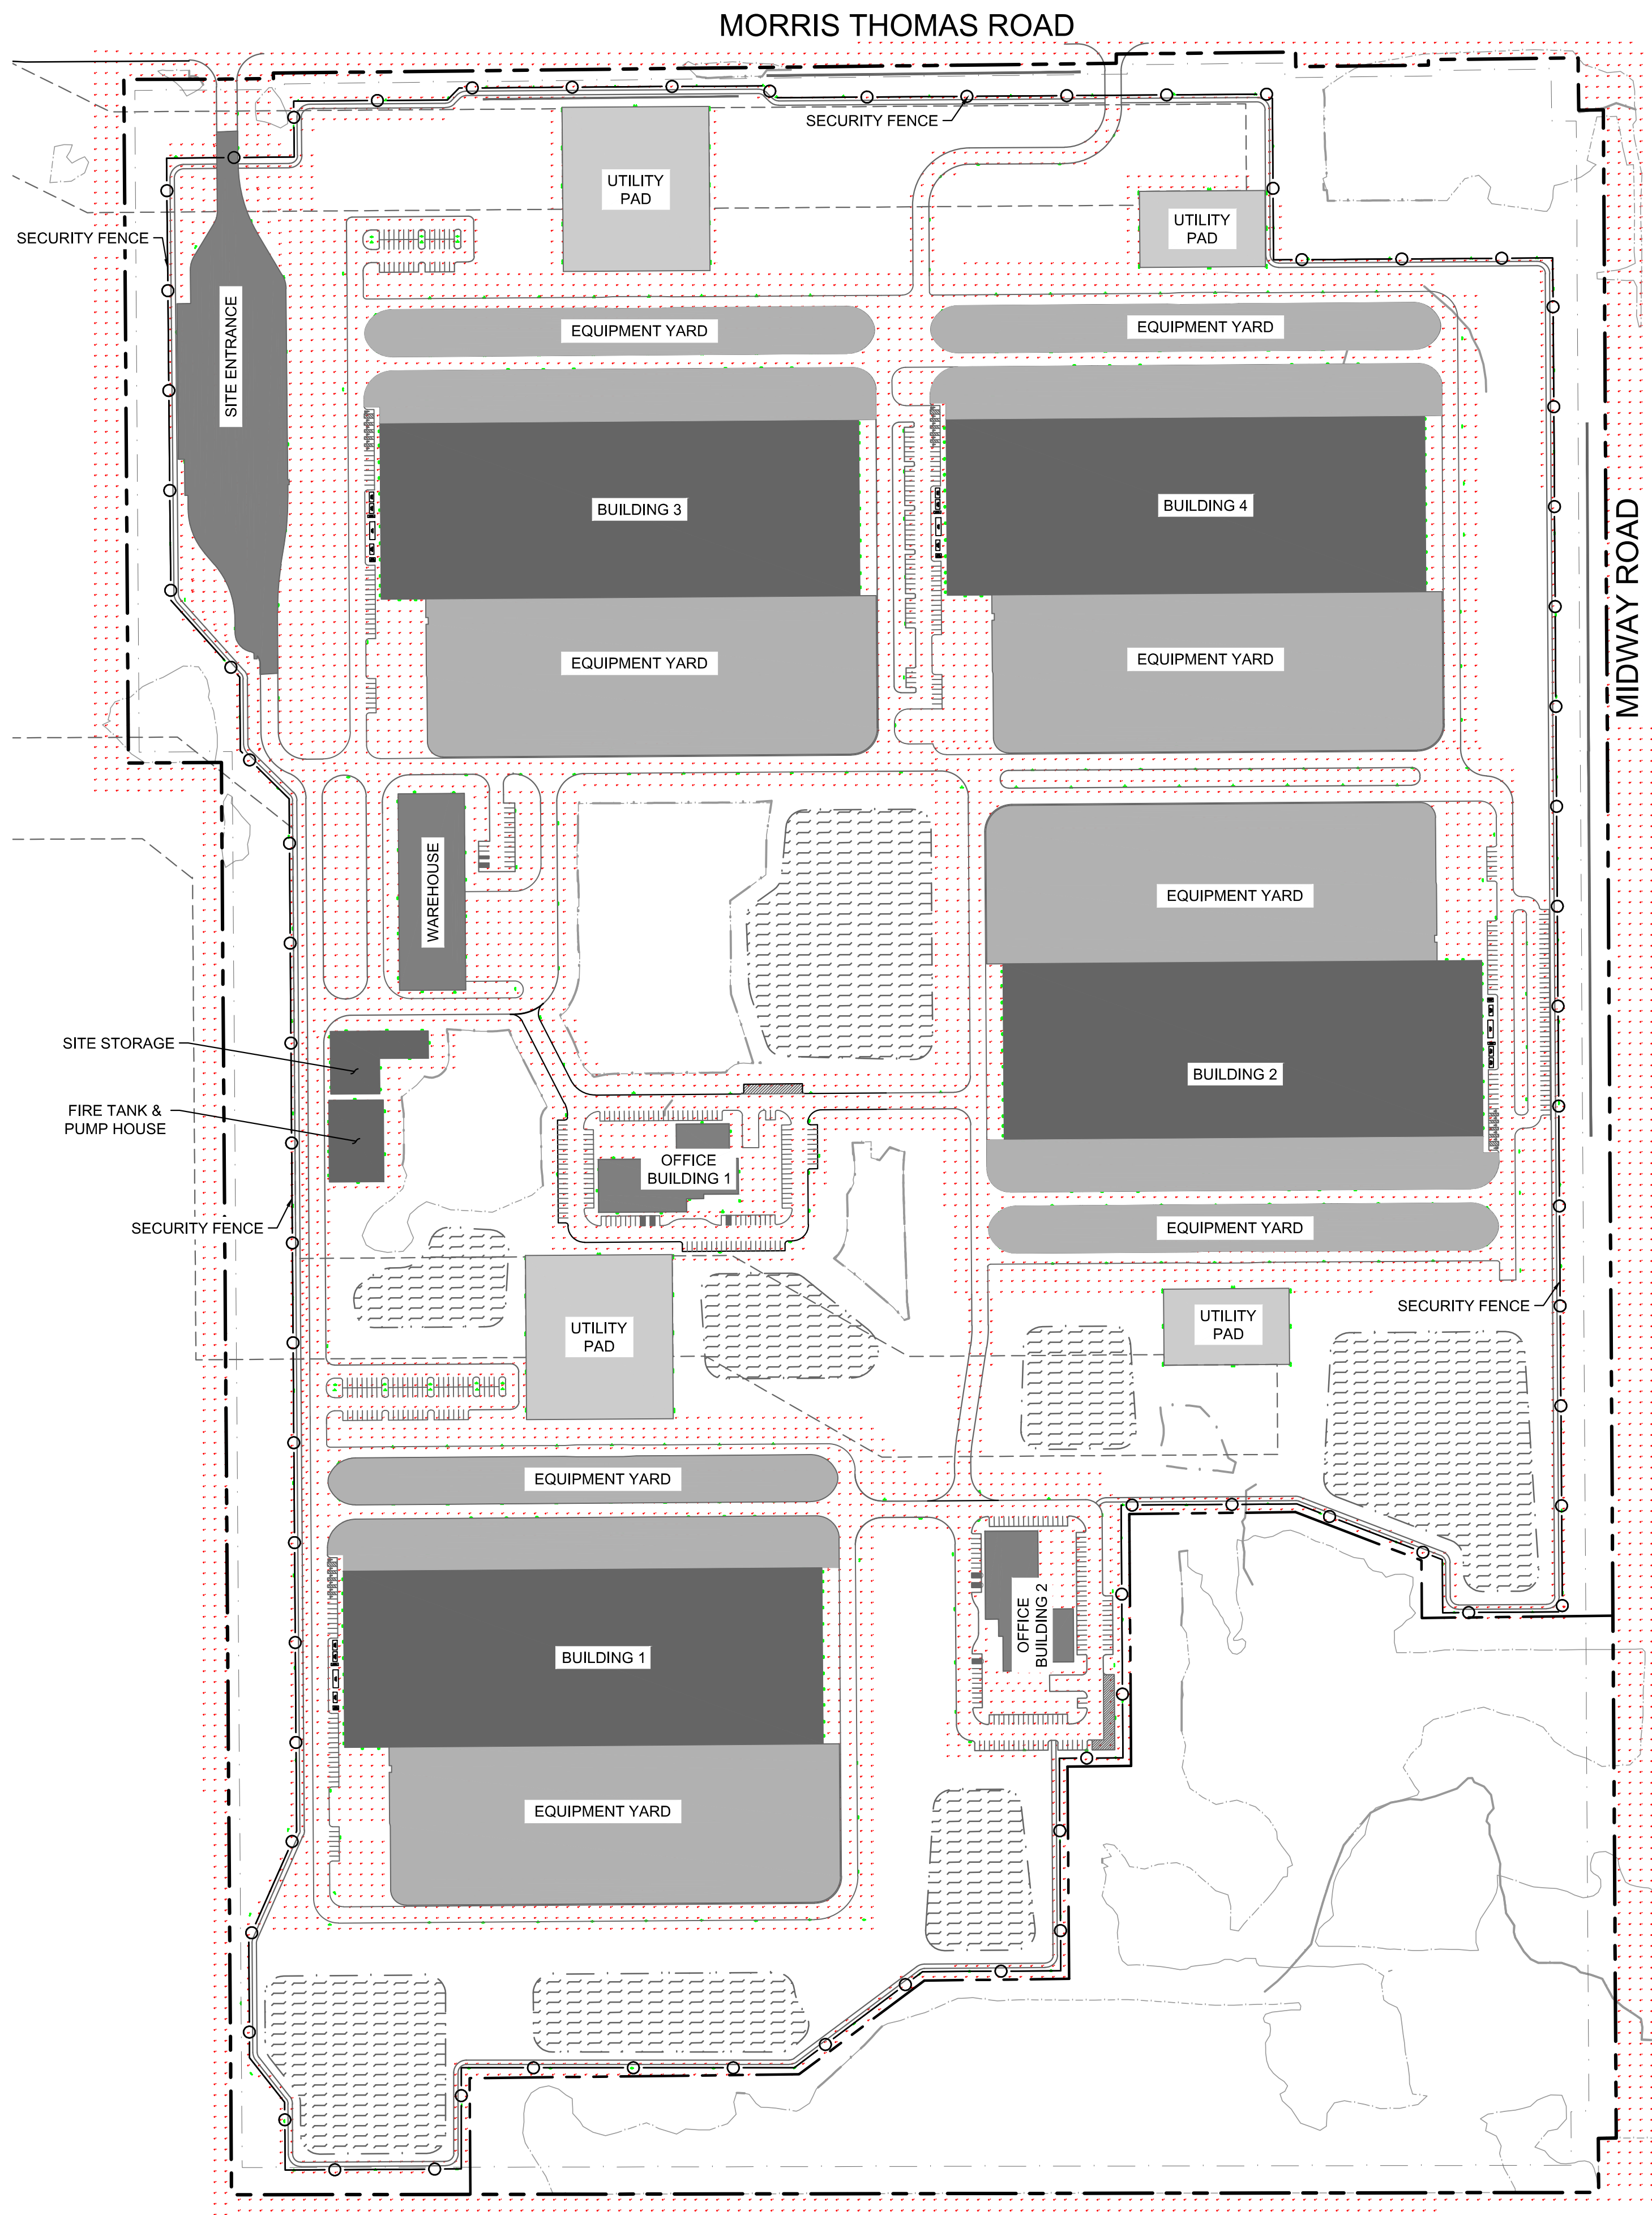


# **Appendix G:** *Landscaping and Lighting Plans*

 
This document, together with the concepts and designs presented herein, as an instrument of service, is intended only for the specific purpose and client for which it was prepared. Reuse of and improper reliance on this document without written authorization and adaptation by Kinley-Horn and Associates, Inc. shall be without liability to Kinley-Horn and Associates, Inc.

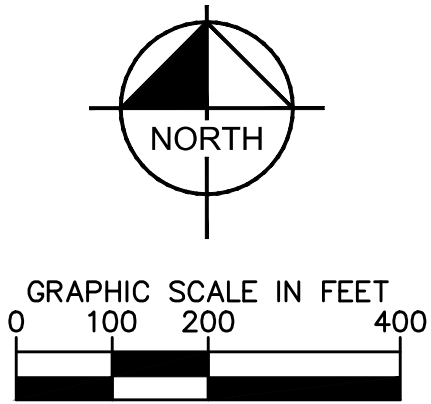


| LIGHTING FIXTURE SCHEDULE |                                                                                                                                                                                                                                                   |          |              |                                                                                |      |         |               |         |             |          |
|---------------------------|---------------------------------------------------------------------------------------------------------------------------------------------------------------------------------------------------------------------------------------------------|----------|--------------|--------------------------------------------------------------------------------|------|---------|---------------|---------|-------------|----------|
| TYPE                      | DESCRIPTION                                                                                                                                                                                                                                       | MOUNTING | MANUFACTURER | MODEL                                                                          | LAMP | WATTAGE | LUMENS OUTPUT | VOLTAGE | COLOR TEMP. | COMMENTS |
| SL1                       | LED SITE/AREA LIGHT, DIE CAST ALUMINUM HOUSING, ROUND TAPERED STEEL POLE WITH INTEGRAL VIBRATION DAMPERS. TYPE: 2 DISTRIBUTION, BI LEVEL MOTION RESPONSE WITH INTEGRAL PASSIVE INFRARED SENSOR. LUMINAIRE, ARM, AND POLE TO HAVE MATCHING FINISH. | POLE     | GARDCO       | (1)<br>ECF-S-32L-530-WW-G2-AR-2-480-BL-IMR17-MGY<br>POLE: TRS-30H-5-DX-MGY-VDA | LED  | 56 W    | 7159 LM       | 480V    | 3000 K      |          |
| SL2                       | SAME AS SL1, TWO LUMINAIR HEADS MOUNTED 180 DEGREES APART.                                                                                                                                                                                        | POLE     | GARDCO       | (2)<br>ECF-S-32L-1A-WW-G2-AR-3-480-BL-IMR17-MGY<br>POLE: TRS-30H-5-DX-MGY-VDA  | LED  | 212 W   | 25438 LM      | 480V    | 3000 K      |          |
| SL3                       | SAME AS SL1, TYPE 5 WIDE DISTRIBUTION                                                                                                                                                                                                             | POLE     | GARDCO       | (1)<br>ECF-S-32L-530-WW-G2-AR-5W-480-BL-IMR17-MGY                              | LED  | 56 W    | 7284 LM       | 480V    | 3000 K      |          |
| SW2                       | WALL SCONCE, DIE CAST ALUMINUM HOUSING, COMFORT TYPE 2 DISTRIBUTION                                                                                                                                                                               | WALL     | GARDCO       | PWS-196L-450-WW-G2-2-480-BL-MGY                                                | LED  | 21 W    | 2040 LM       | 480V    | 3000 K      |          |
| T2                        | LED SITE/AREA LIGHT, DIE CAST ALUMINUM HOUSING, LUMINAIRE AND ARM TO HAVE MATCHING FINISH. NOTE: HEADS TO BE MOUNTED ATOP CONCRETE SECURITY POLE.                                                                                                 | POLE     | GARDCO       | (3 AT 289W)<br>PFF-13BL-700-WW-G2-SF-SP-HV U-SP2-MGY                           | LED  | 867 W   | 130857 LM     | 480V    | 3000 K      |          |

| PHOTOMETRIC CALCULATIONS |              |              |              |
|--------------------------|--------------|--------------|--------------|
| CALCULATION ZONE NAME    | AVERAGE (FC) | MINIMUM (FC) | MAXIMUM (FC) |
| NORTHERN PROPERTY LINE   | 0.0          | 0.0          | 0.4          |
| EASTERN PROPERTY LINE    | 0.0          | 0.0          | 0.0          |
| SOUTHERN PROPERTY LINE   | 0.0          | 0.0          | 0.1          |
| WESTERN PROPERTY LINE    | 0.0          | 0.0          | 0.3          |

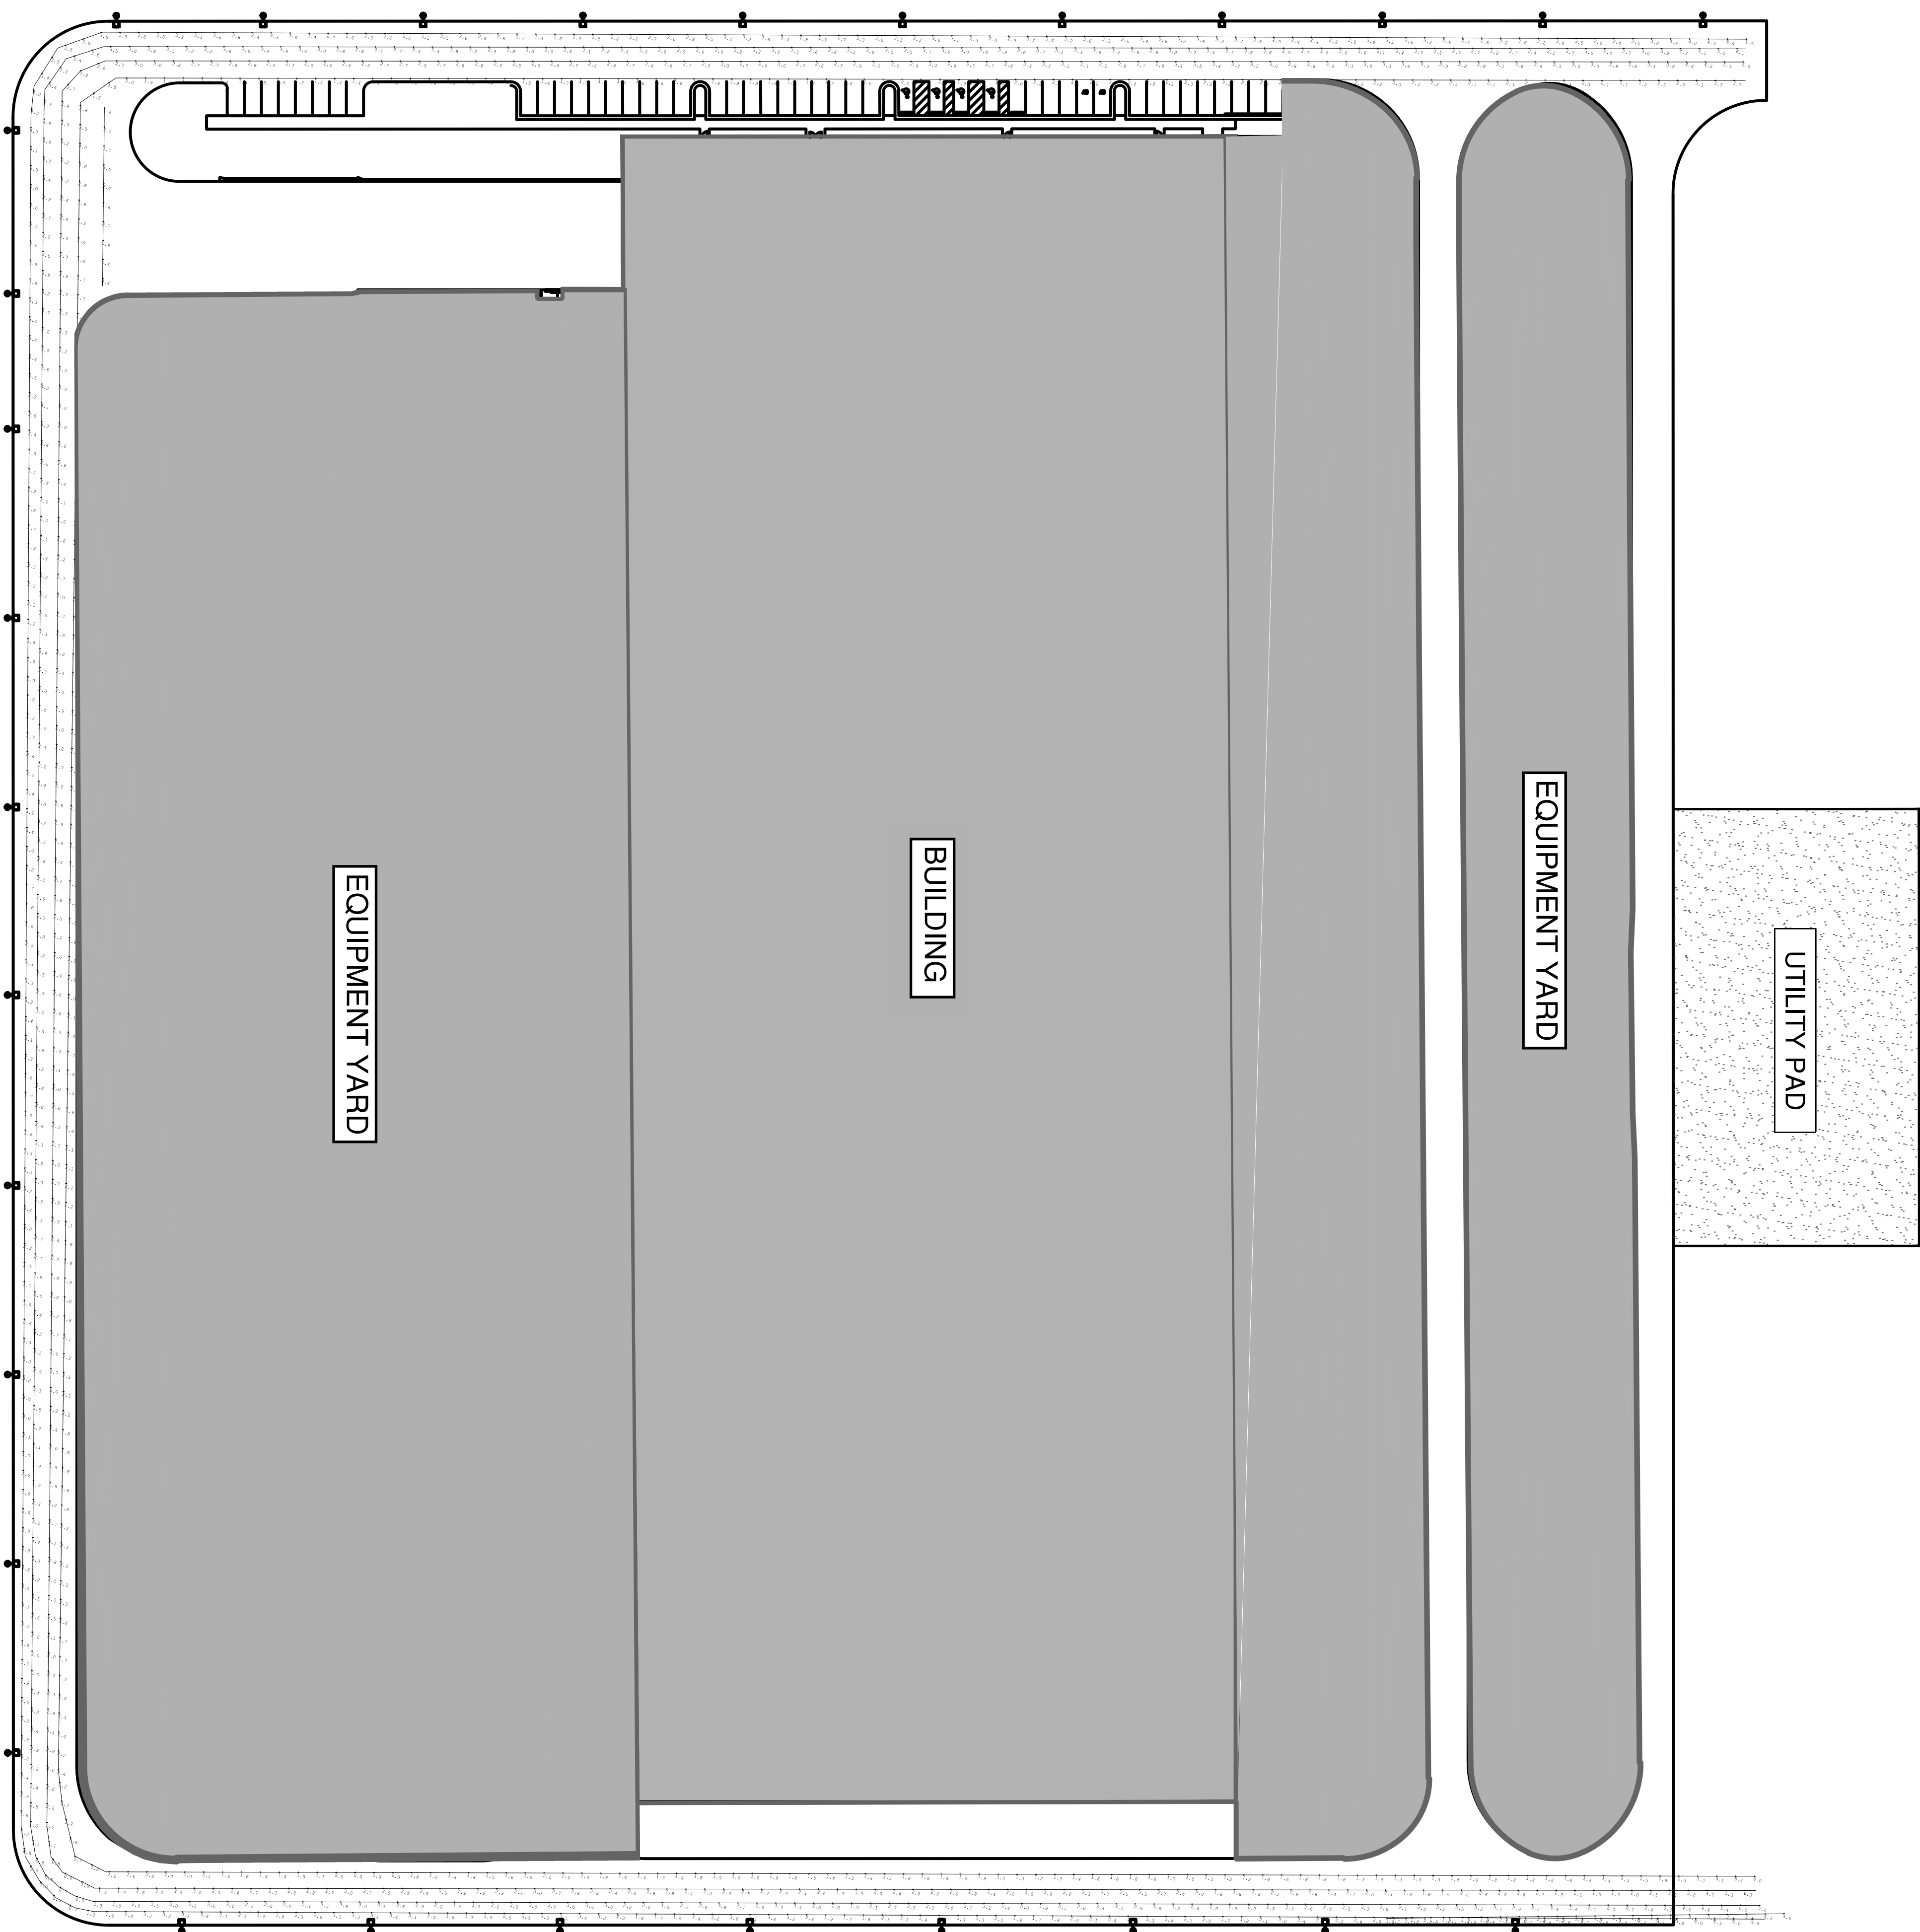
# LEGEND

|                                                                                     |                                                               |
|-------------------------------------------------------------------------------------|---------------------------------------------------------------|
|    | PROPERTY LINE                                                 |
|  | SETBACK LINE                                                  |
|  | DRAINAGE AND UTILITY EASEMENT                                 |
|  | PROPOSED SECURITY FENCE                                       |
|  | PROPOSED RETAINING WALL                                       |
|  | PROPOSED CURB AND GUTTER                                      |
|  | WETLAND PRESERVATION                                          |
|  | <u>STORM WATER MANAGEMENT</u><br>SEE GRADING PLAN FOR DETAILS |
|  | PHOTOMETRIC MEASUREMENT (FC)                                  |
|  | LIGHTING FIXTURE                                              |



Know what's **below**.  
**Call** before you dig.

[illegible]

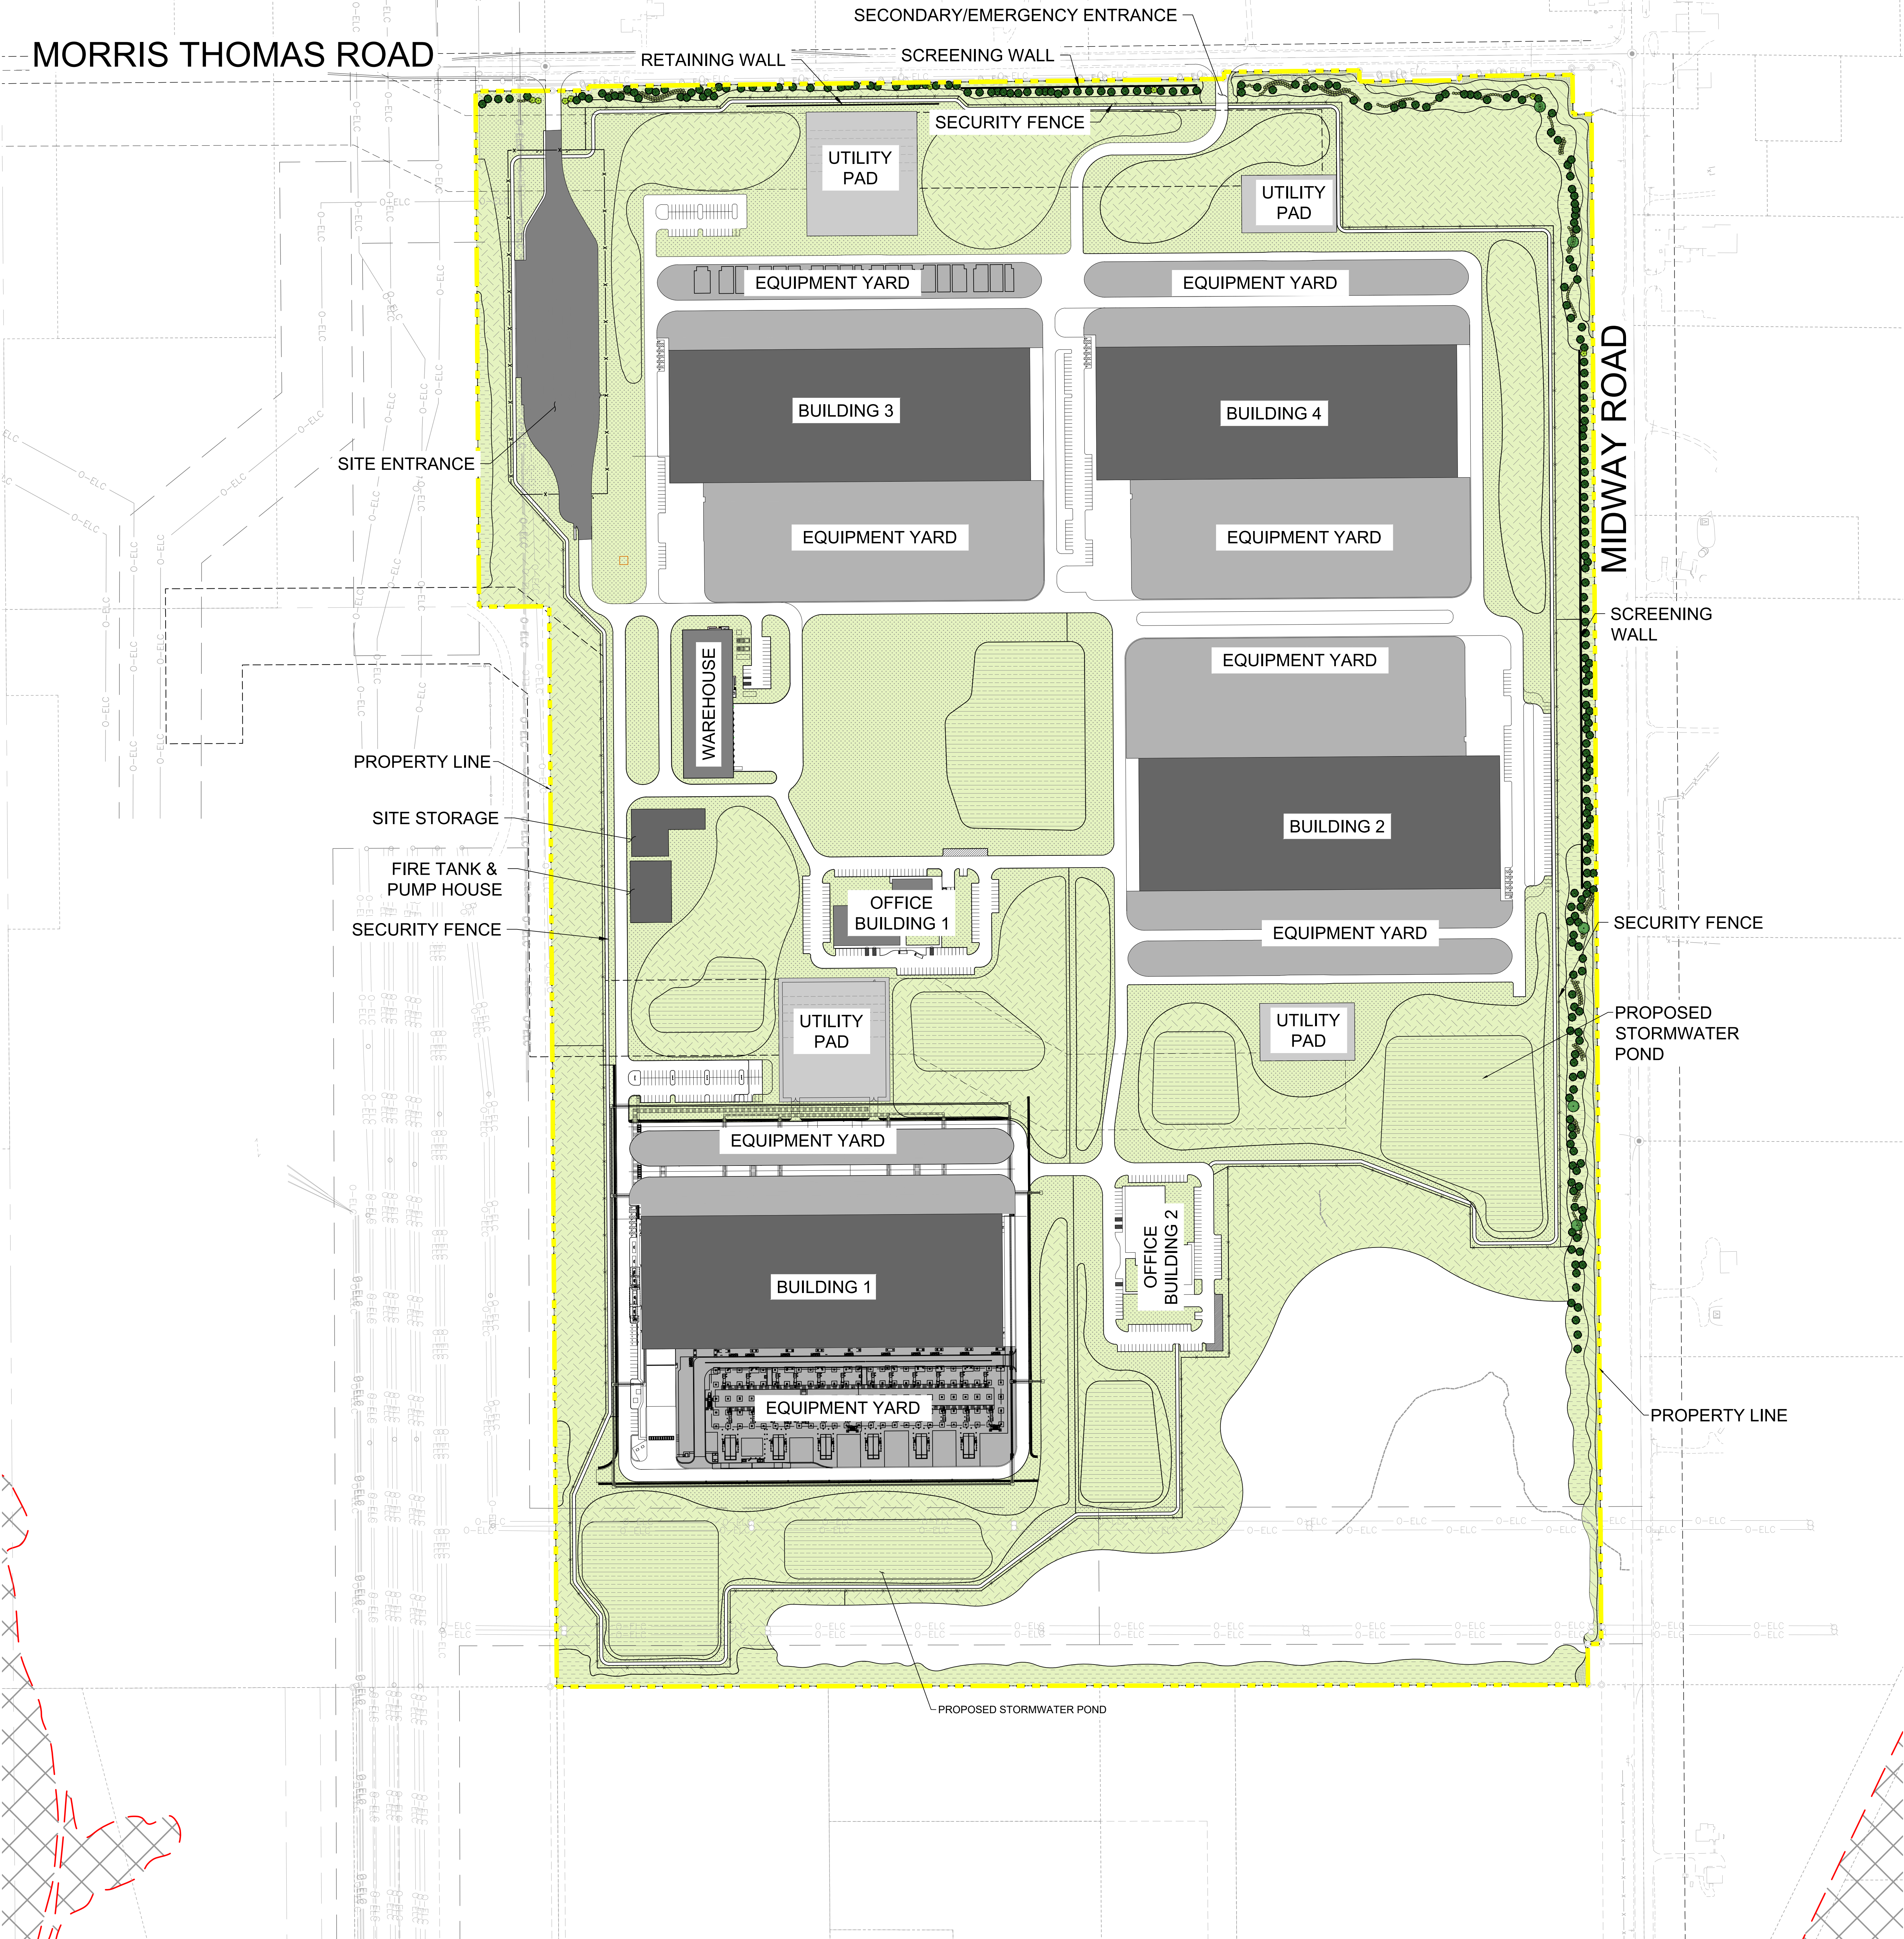


| Illuminance Targets per IESNA 10th Edition<br>Footcandles (Lux)              |                         |                         |                         |                         |
|------------------------------------------------------------------------------|-------------------------|-------------------------|-------------------------|-------------------------|
| Area                                                                         | Average<br>(Horizontal) | Minimum<br>(Horizontal) | Uniformity<br>(Ave/Min) | Uniformity<br>(Max/Min) |
| Building<br>Perimeter                                                        | n/a                     | 1.0 @ Grade<br>(11)     | n/a                     | n/a                     |
| Utility Pad                                                                  | 2.0 @ Grade<br>(21)     | n/a                     | n/a                     | 10:1                    |
| Security Fence*,<br>Site Entrance,<br>Roadways,<br>Parking Lots,<br>Walkways | 1.0 @ Grade<br>(11)     | 0.3 @ Grade<br>(3)      | 3:1                     | n/a                     |

\*Fence lighting intends to ensure that there is an illumination level at the fence and not beyond

|                      |                                                                                           |                                         |                          |  |                                                                                                                                                                                        |     |           |      |    |
|----------------------|-------------------------------------------------------------------------------------------|-----------------------------------------|--------------------------|--|----------------------------------------------------------------------------------------------------------------------------------------------------------------------------------------|-----|-----------|------|----|
| SHEET NUMBER<br>---- | HERMANTOWN INDUSTRIAL<br><br>PREPARED FOR<br>HARMONY GROUP LLC<br><br>HERMANTOWNMINNESOTA | TYPICAL BUILDING<br>PHOTOMETRIC<br>PLAN | KHA PROJECT<br>161333002 |  | <div>Kimley»Horn</div> <div>© 2025 KIMLEY-HORN AND ASSOCIATES, INC.<br/>11995 SINGLETREE LANE, SUITE 225, EDEN PRAIRIE, MN 55344<br/>PHONE: 612-315-1272<br/>WWW.KIMLEY-HORN.COM</div> |     |           |      |    |
|                      |                                                                                           |                                         | DATE<br>10/17/2025       |  |                                                                                                                                                                                        |     |           |      |    |
|                      |                                                                                           |                                         | SCALE NOT TO SCALE       |  |                                                                                                                                                                                        |     |           |      |    |
|                      |                                                                                           |                                         | DESIGNED BY              |  |                                                                                                                                                                                        |     |           |      |    |
|                      |                                                                                           |                                         | DRAWN BY                 |  |                                                                                                                                                                                        |     |           |      |    |
|                      |                                                                                           |                                         | CHECKED BY               |  |                                                                                                                                                                                        |     |           |      |    |
|                      |                                                                                           |                                         |                          |  |                                                                                                                                                                                        | No. | REVISIONS | DATE | BY |

MORRIS THOMAS ROAD



CONCEPT PLANT SCHEDULE

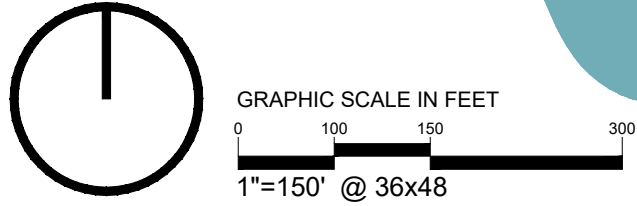
| COMMON NAME                                   | BOTANICAL NAME                 | CONT     | CAL       |
|-----------------------------------------------|--------------------------------|----------|-----------|
| <strong>CONIFEROUS TREE</strong>              |                                |          |           |
| BALSAM FIR                                    | ABIES BALSAMEA                 | B & B    | 8' HT.    |
| JACK PINE                                     | PINUS BANKSIANA                | B & B    | 8' HT.    |
| TAMARACK                                      | LARIX LARICINA                 | B & B    | 8' HT.    |
| BLACK SPRUCE                                  | PICEA MARIANA                  | B & B    | 8' HT.    |
| RED PINE                                      | PINUS RESINOSA                 | B & B    | 8' HT.    |
| WHITE SPRUCE                                  | PICEA GLAUCA                   | B & B    | 8' HT.    |
| WHITE CEDAR                                   | THUJA OCCIDENTALIS             | B & B    | 8' HT.    |
| WHITE PINE                                    | PINUS STROBUS                  | B & B    | 8' HT.    |
| <strong>OVERSTORY TREE</strong>               |                                |          |           |
| NORTHERN PIN OAK                              | QUERCUS ELLIPSOIDALIS          | B & B    | 2.5' CAL. |
| NORTHWOOD MAPLE                               | ACER RUBRUM 'NORTHWOOD'        | B & B    | 2.5' CAL. |
| WHITE OAK                                     | QUERCUS ALBA                   | B & B    | 2.5' CAL. |
| RED OAK                                       | QUERCUS RUBRA                  | B & B    | 2.5' CAL. |
| SUGAR MAPLE                                   | ACER SACCHARUM                 | B & B    | 2.5' CAL. |
| SWAMP WHITE OAK                               | QUERCUS BICOLOR                | B & B    | 2.5' CAL. |
| <strong>UNDERSTORY / ORNAMENTAL TREE</strong> |                                |          |           |
| YELLOW BIRCH                                  | BETULA ALLEGHANIENSIS          | B & B    | 2" CAL.   |
| PAPER BIRCH                                   | BETULA Papyrifera              | B & B    | 2" CAL.   |
| PRAIRIE DREAMS PAPER BIRCH                    | BETULA Papyrifera 'VAREN'      | B & B    | 2" CAL.   |
| PRAIRIE ROSE CRABAPPLE                        | MALUS IOENSIS 'PRAIRIE ROSE'   | B & B    | 2" CAL.   |
| QUAKING ASPEN                                 | POPULUS TREMULOIDES            | B & B    | 2" CAL.   |
| QUAKING ASPEN CLUMP                           | POPULUS TREMULOIDES            | B & B    | 6' HT.    |
| RIVER BIRCH MULTI-TRUNK                       | BETULA NIGRA                   | B & B    | 6' HT.    |
| SHOWY MOUNTAIN ASH                            | SORBUS DECORA                  | B & B    | 2" CAL.   |
| <strong>COMMON NAME</strong>                  |                                |          |           |
| <strong>DECIDUOUS SHRUBS</strong>             |                                |          |           |
| BOG BIRCH                                     | BETULA PUMILA                  | #7 CONT. | 5' O.C.   |
| BLACK CHOKEBERRY                              | ARONIA MELANOCARPA ELATA       | #5 CONT. | 5' O.C.   |
| DWARF BUSH HONEYSUCKLE                        | DIERVILLA LONICERA             | #5 CONT. | 3' O.C.   |
| JUNE BERRY / SERVICE BERRY                    | AMELANCHIER ALNIFOLIA          | #5 CONT. | 10' O.C.  |
| PUSSY WILLOW                                  | SALIX DISCOLOR                 | #5 CONT. | 5' O.C.   |
| REGENT SERVICE BERRY                          | AMELANCHIER ALNIFOLIA 'REGENT' | #5 CONT. | 5' O.C.   |
| LABRADOR TEA                                  | RHODODENDRON GROENLANDICUM     | #5 CONT. | 5' O.C.   |
| FLAME WILLOW                                  | SALIX X 'FLAME'                | #5 CONT. | 5' O.C.   |

SEED MIX / SOD SCHEDULE WITHIN L.O.D.

| SYMBOL                | DESCRIPTION                                            | QTY         |
|-----------------------|--------------------------------------------------------|-------------|
| <strong>SEED</strong> |                                                        |             |
| [Symbol]              | TYPE 1: MNDOT MIX 36-312 WOODLAND EDGE NE              | 0.83 ACRES  |
| [Symbol]              | TYPE 2: MNDOT MIX 38-341 POLLINATOR PLOT NE            | 0 ACRES     |
| [Symbol]              | TYPE 3: MNDOT MIX 32-351 MID DIVERSITY MOIST BUFFER NE | 5.56 ACRES  |
| [Symbol]              | TYPE 4: CUSTOM SEED MIX - NATIVE GRASSES NE            | 31.10 ACRES |
| [Symbol]              | TYPE 6: MNDOT NB - NORTHERN BOULEVARD                  | 36.51 ACRES |
|                       | TOTAL                                                  | 74.0 ACRES  |
| [Symbol]              | TYPE 5: MNDOT MIX 33-361 STORMWATER NE                 | 14.78 ACRES |

NOTE:  
QUANTITIES ON PLAN SUPERSEDE LIST QUANTITIES IN THE EVENT OF A DISCREPANCY.

ABBREVIATIONS:  
B&B = BALLED AND BURLAPPED CAL = CALIPER HT. = HEIGHT  
MIN. = MINIMUM O.C. = ON CENTER SP. = SPECIES QTY. = QUANTITY



LANDSCAPE SUMMARY

| SCREENING REQUIREMENTS |                                                                                         |
|------------------------|-----------------------------------------------------------------------------------------|
| REQUIRED:              | ALL TRASH, LOADING, AND STORAGE AREAS TO BE FULLY SCREENED FROM THE PUBLIC RIGHT-OF-WAY |
| PROVIDED:              | ALL TRASH, LOADING, AND STORAGE AREAS FULLY SCREENED FROM THE PUBLIC RIGHT-OF-WAY       |
| BUFFER REQUIREMENTS    |                                                                                         |
| REQUIRED:              | ALL ABUTTING RESIDENTIAL PROPERTIES TO BE BUFFERED                                      |
| PROVIDED:              | ALL ABUTTING RESIDENTIAL PROPERTIES BUFFERED                                            |

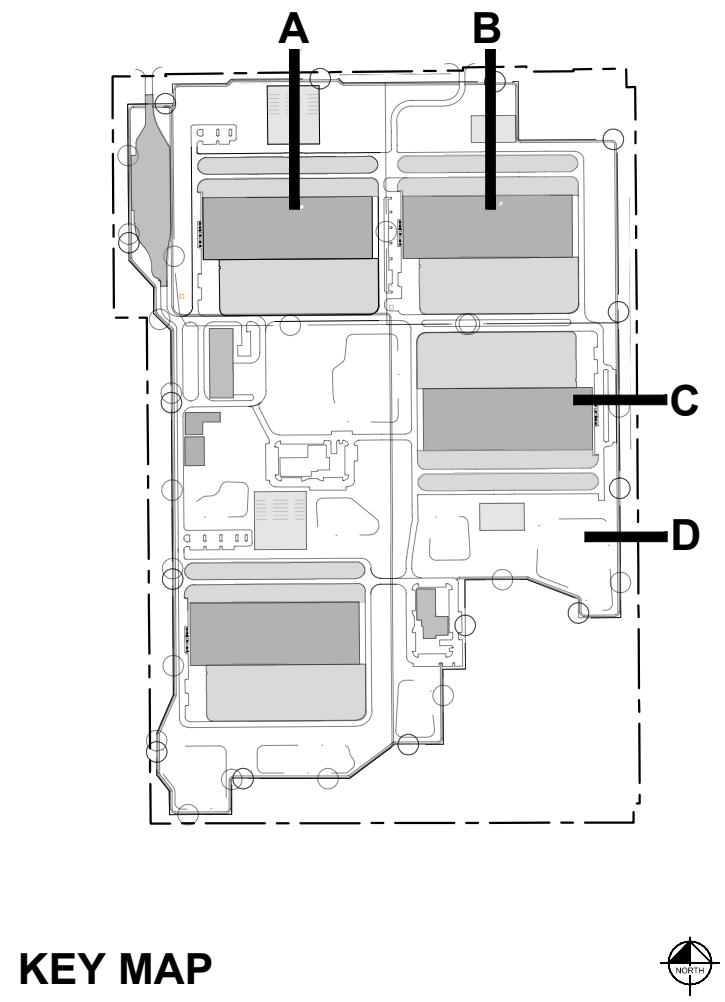
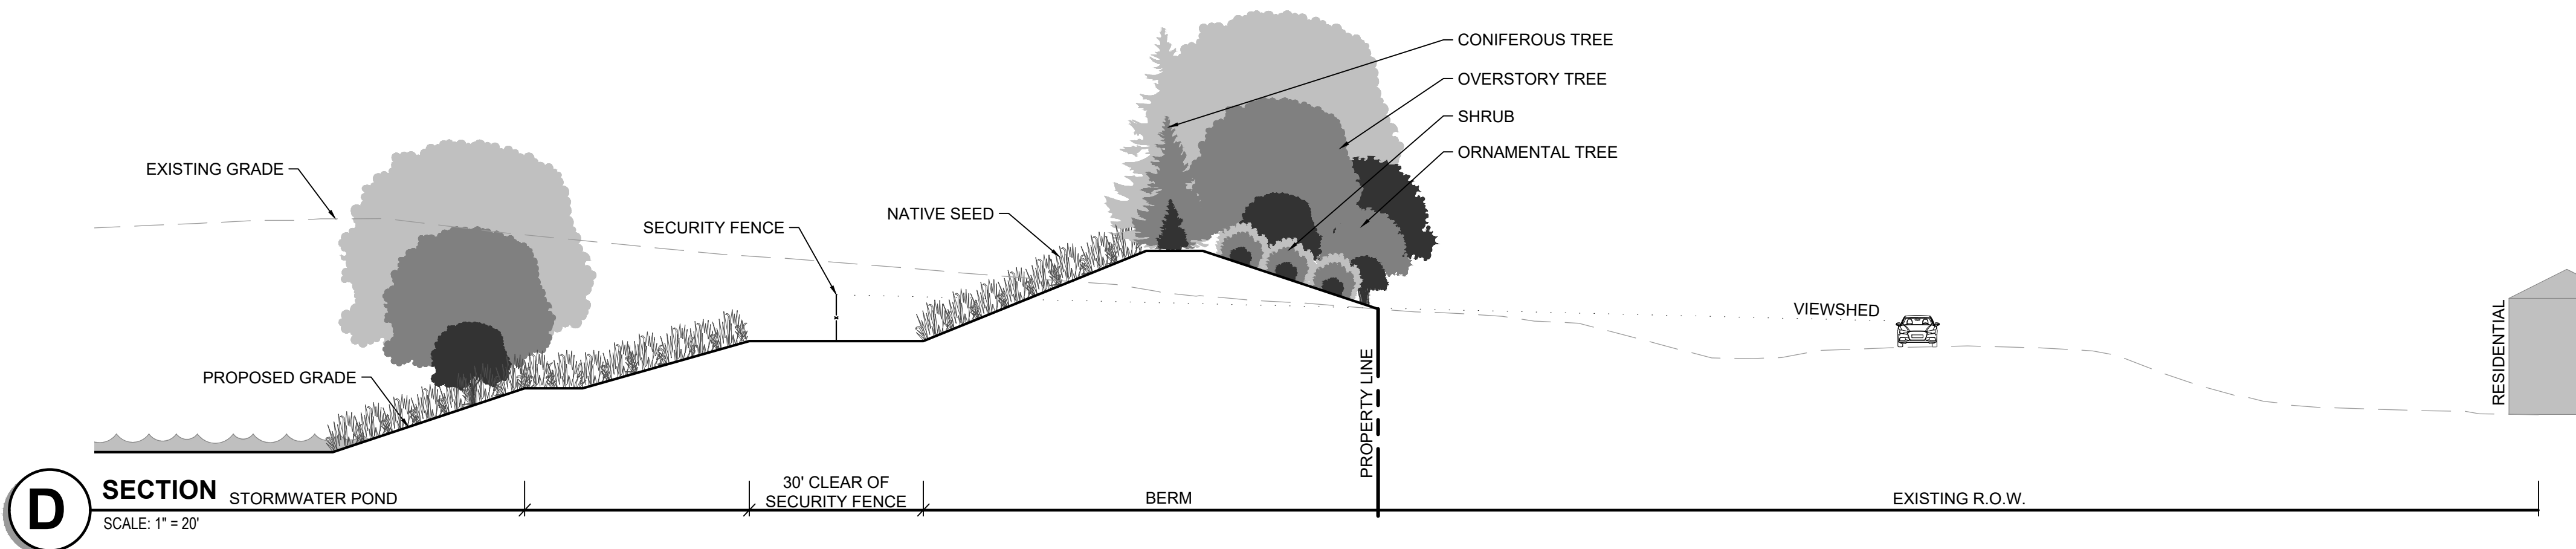
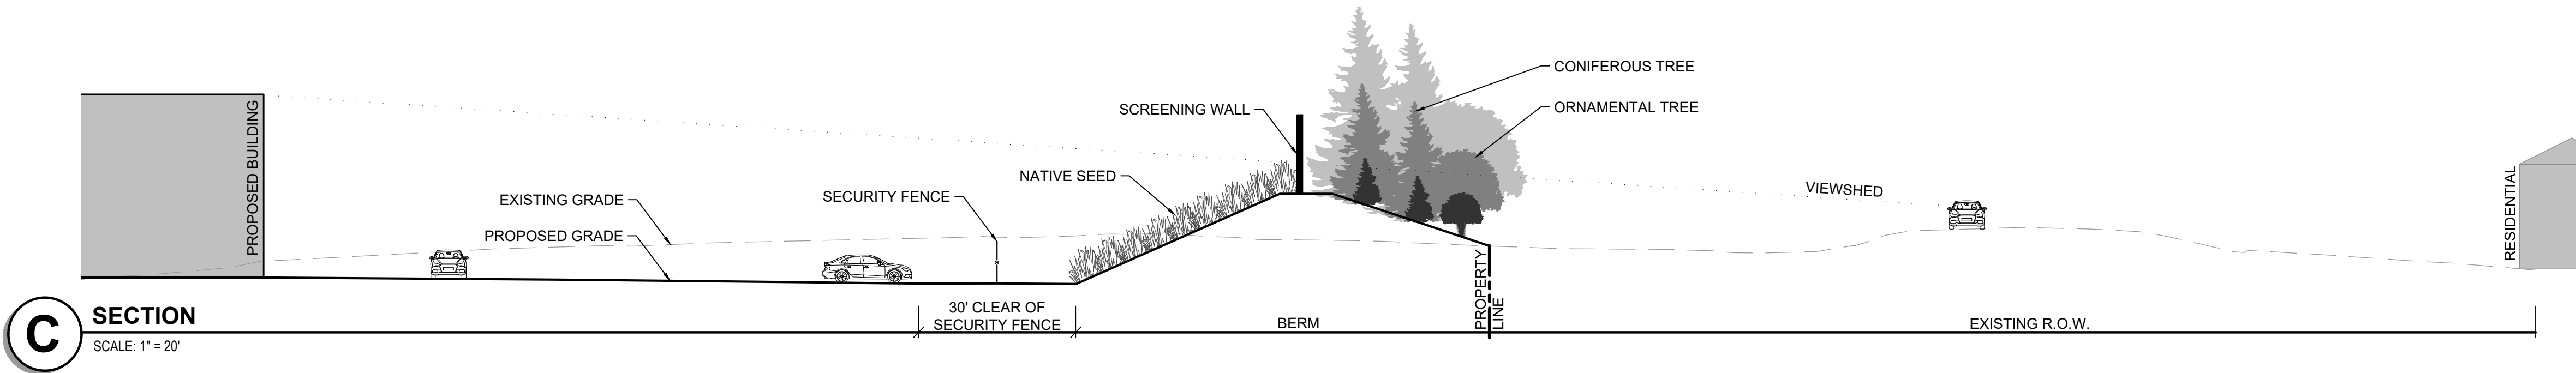
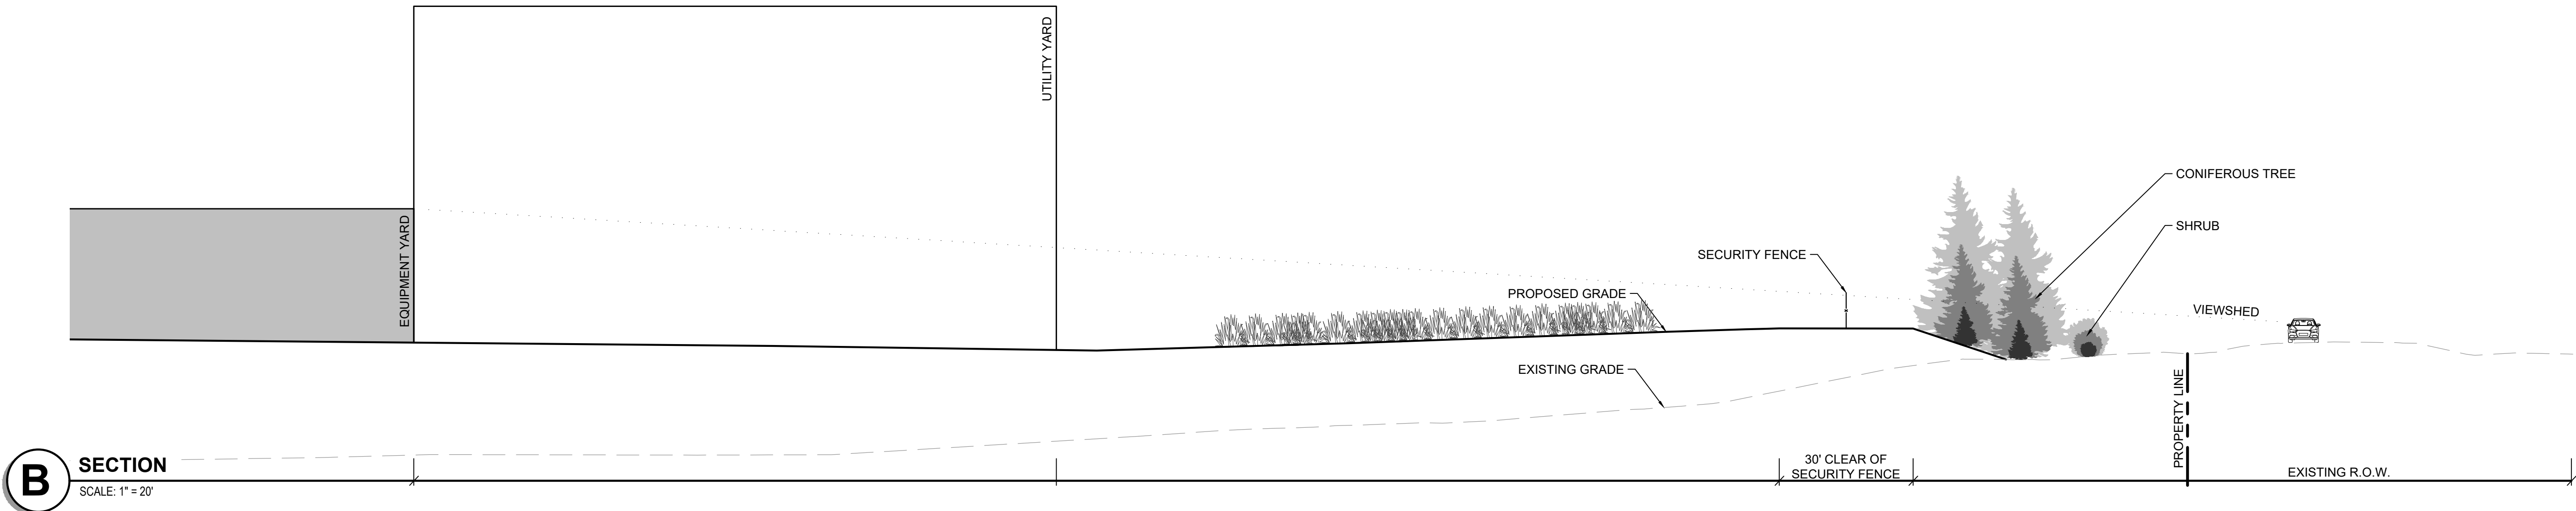
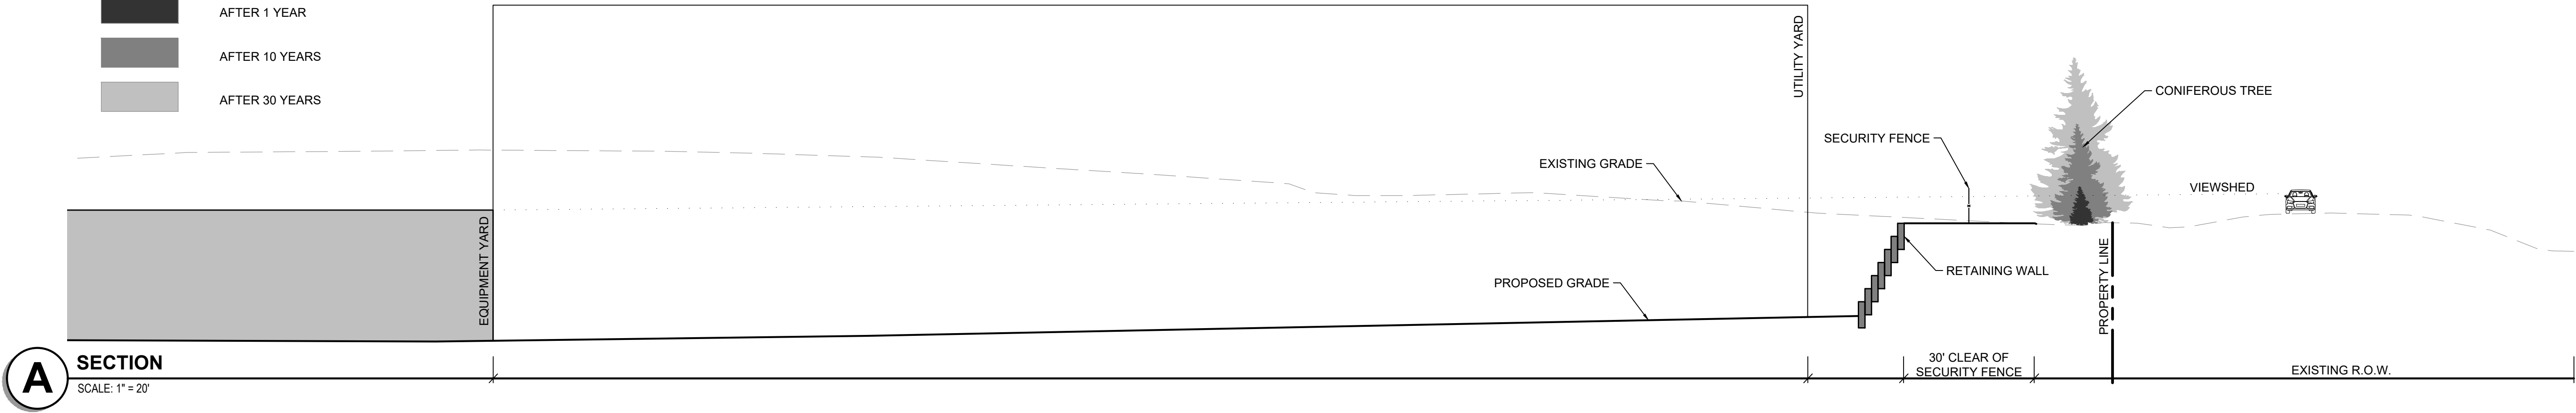
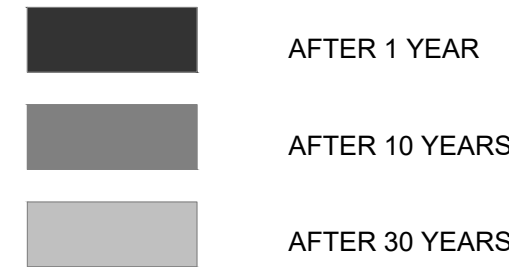
HERMANTOWN INDUSTRIAL

Hermantown, MN | St. Louis County  
July 2025

Kimley»Horn

This document, together with the concepts and designs presented herein, as an instrument of service, is intended only for the specific purpose and client for which it was prepared. Reuse of and improper reliance on this document without written authorization and adaptation by Kimley-Horn and Associates, Inc. shall be without liability to Kimley-Horn and Associates, Inc.

### VEGETATION GROWTH LEGEND

[illegible]